


FOURTH FLOOR LIGHTING PLAN
SCALE: 1/8" = 1'-0"

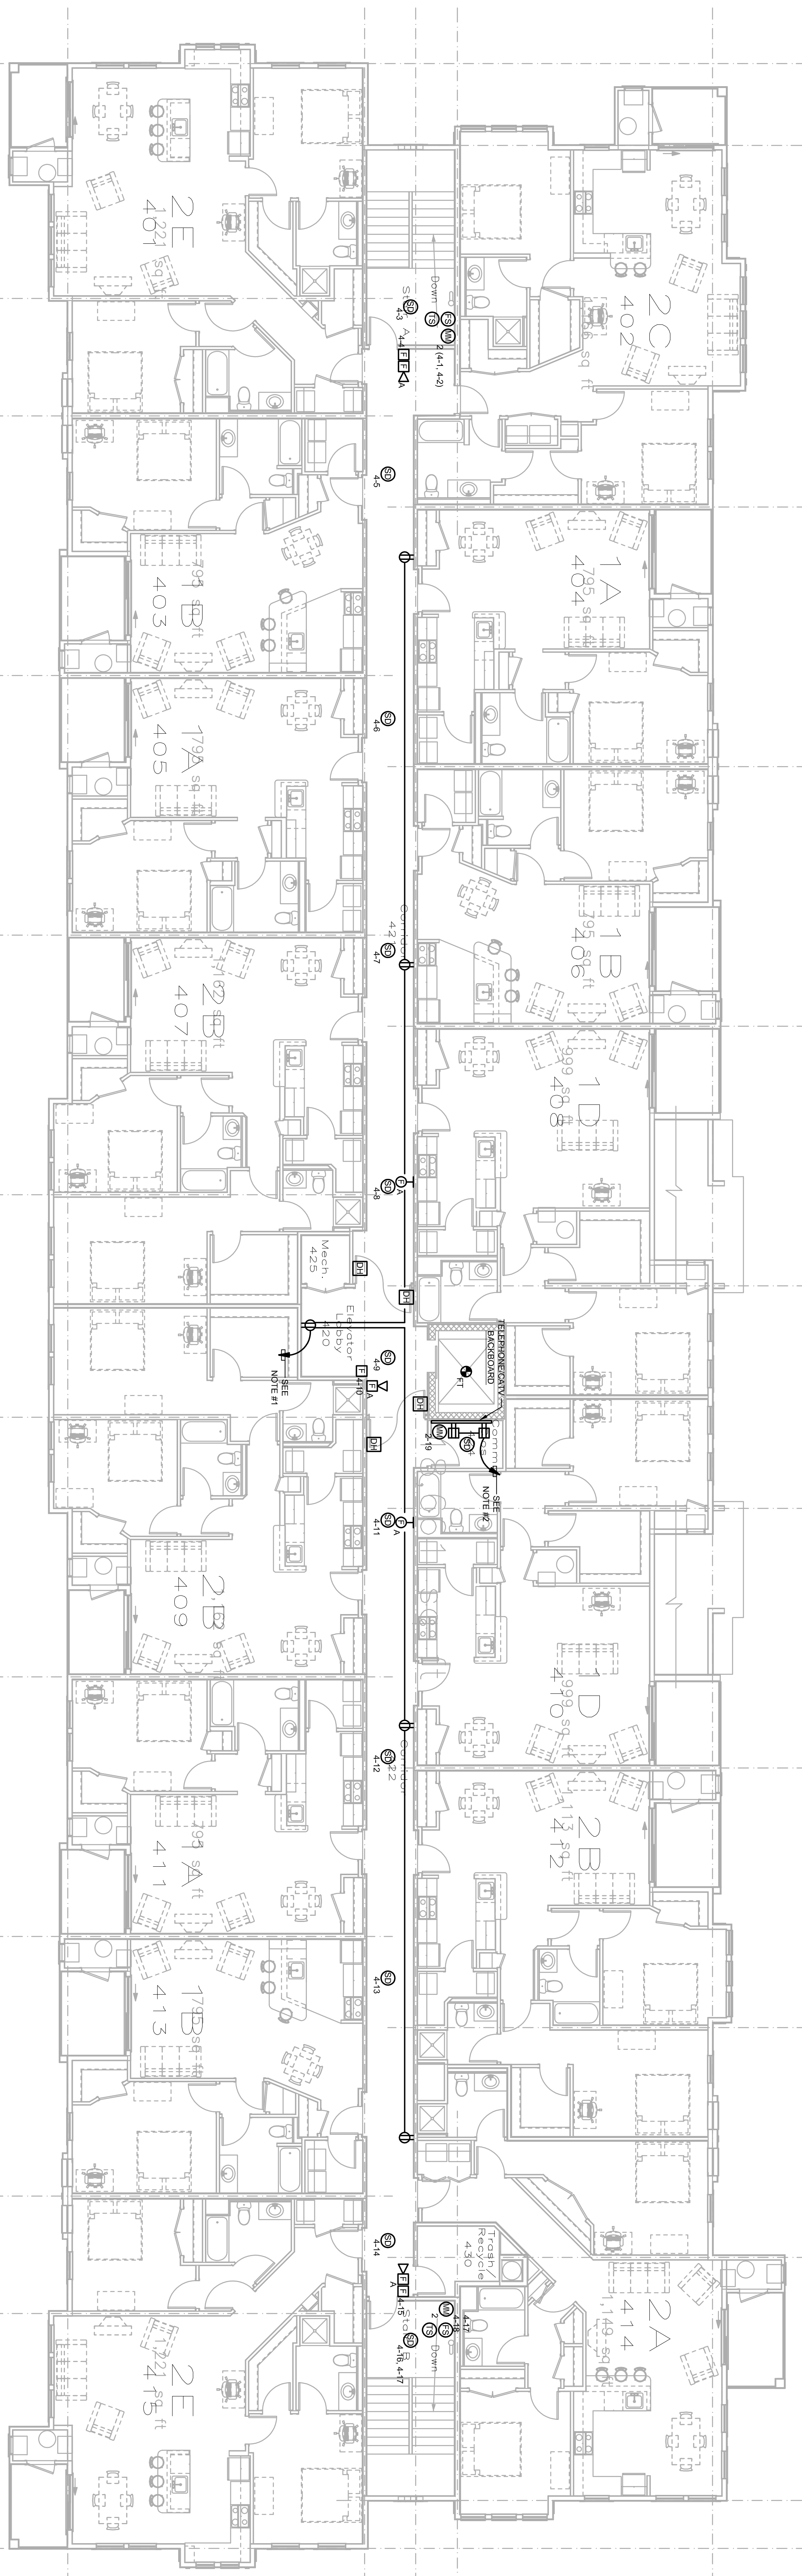

FOURTH FLOOR ELECTRICAL PLAN
SCALE: 1/8" = 1'-0"

- NOTES:
1. RECEPTACLES SHALL BE WIRRED AS FOLLOWS:
BUILDING NO.1 HP-23
BUILDING NO.2 HP-23
BUILDING NO.3 HP-23
 2. RECEPTACLES SHALL BE WIRRED AS FOLLOWS:
BUILDING NO.1 HP-24
BUILDING NO.2 HP-24
BUILDING NO.3 HP-24
 3. LIGHTING FIXTURES SHALL BE WIRRED AS FOLLOWS:
BUILDING NO.1 EL-45
BUILDING NO.2 EL-45
BUILDING NO.3 HP-25
 4. LIGHTING FIXTURES SHALL BE WIRRED AS FOLLOWS:
BUILDING NO.1 HP-25
BUILDING NO.2 HP-25
BUILDING NO.3 HP-25