




UNIT '2C' ELECTRICAL PLAN  
SCALE: 1/4" = 1'-0"

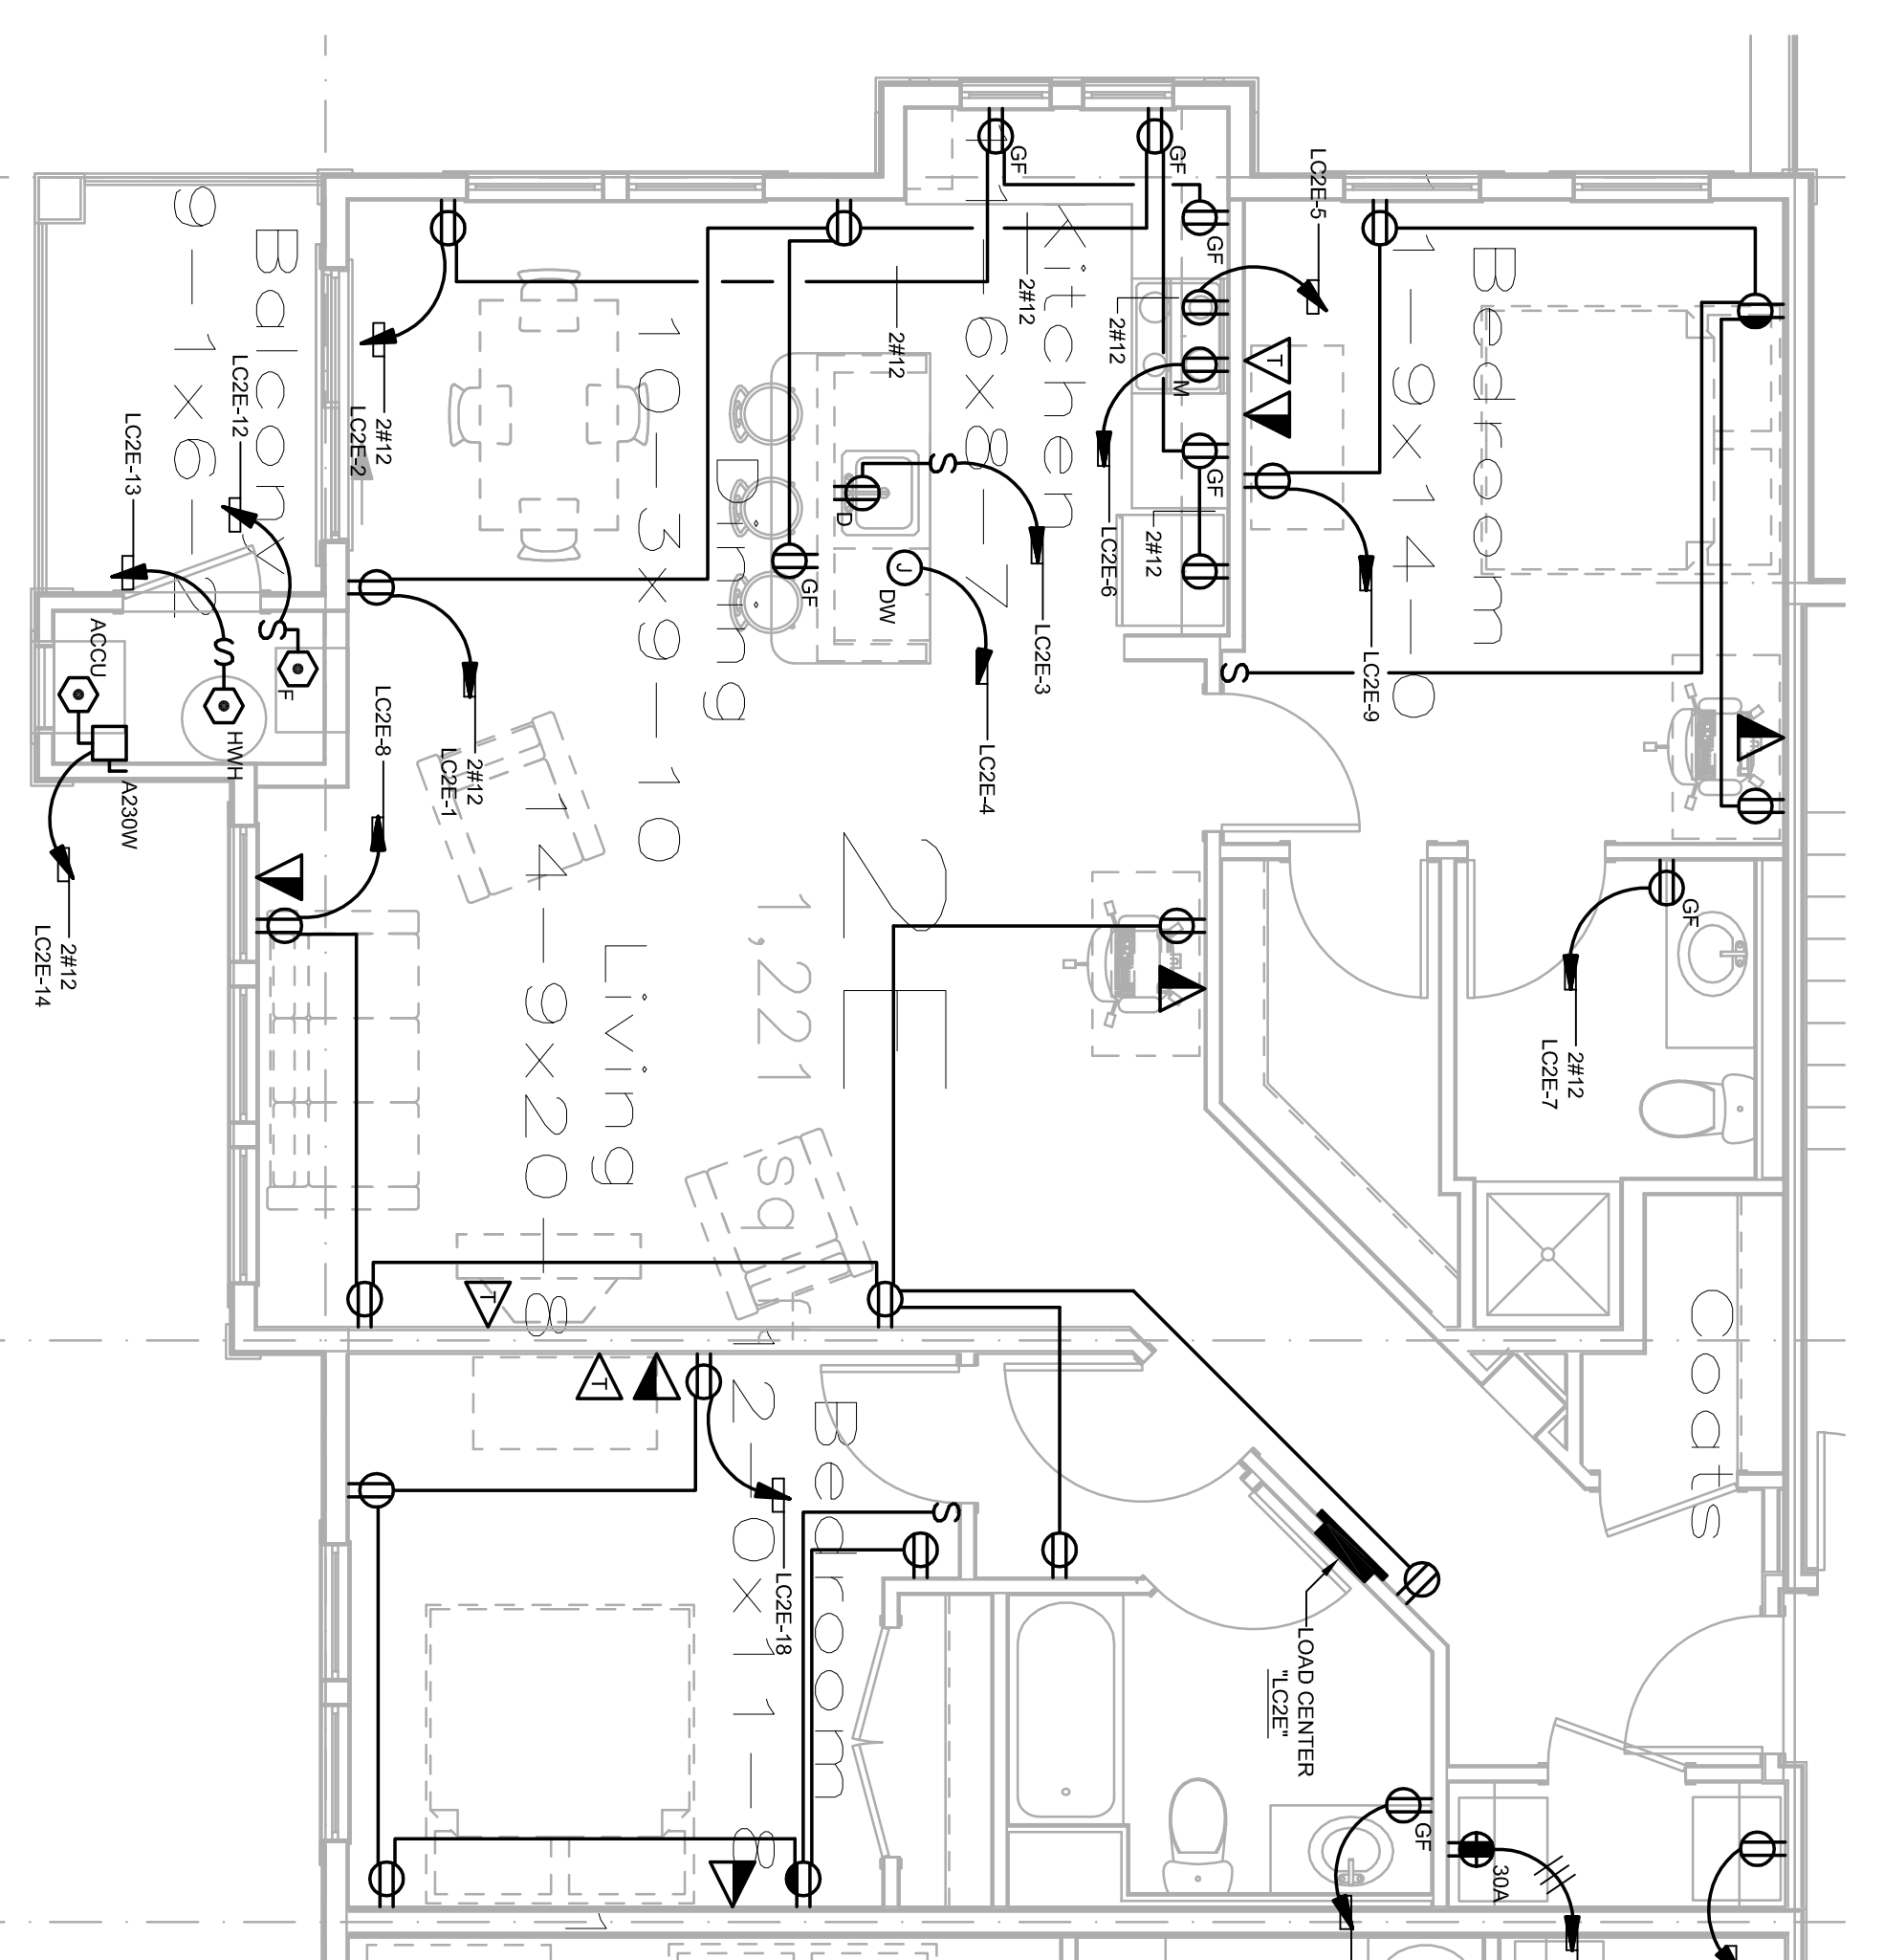


UNIT '2E' ELECTRICAL PLAN  
SCALE: 1/4" = 1'-0"

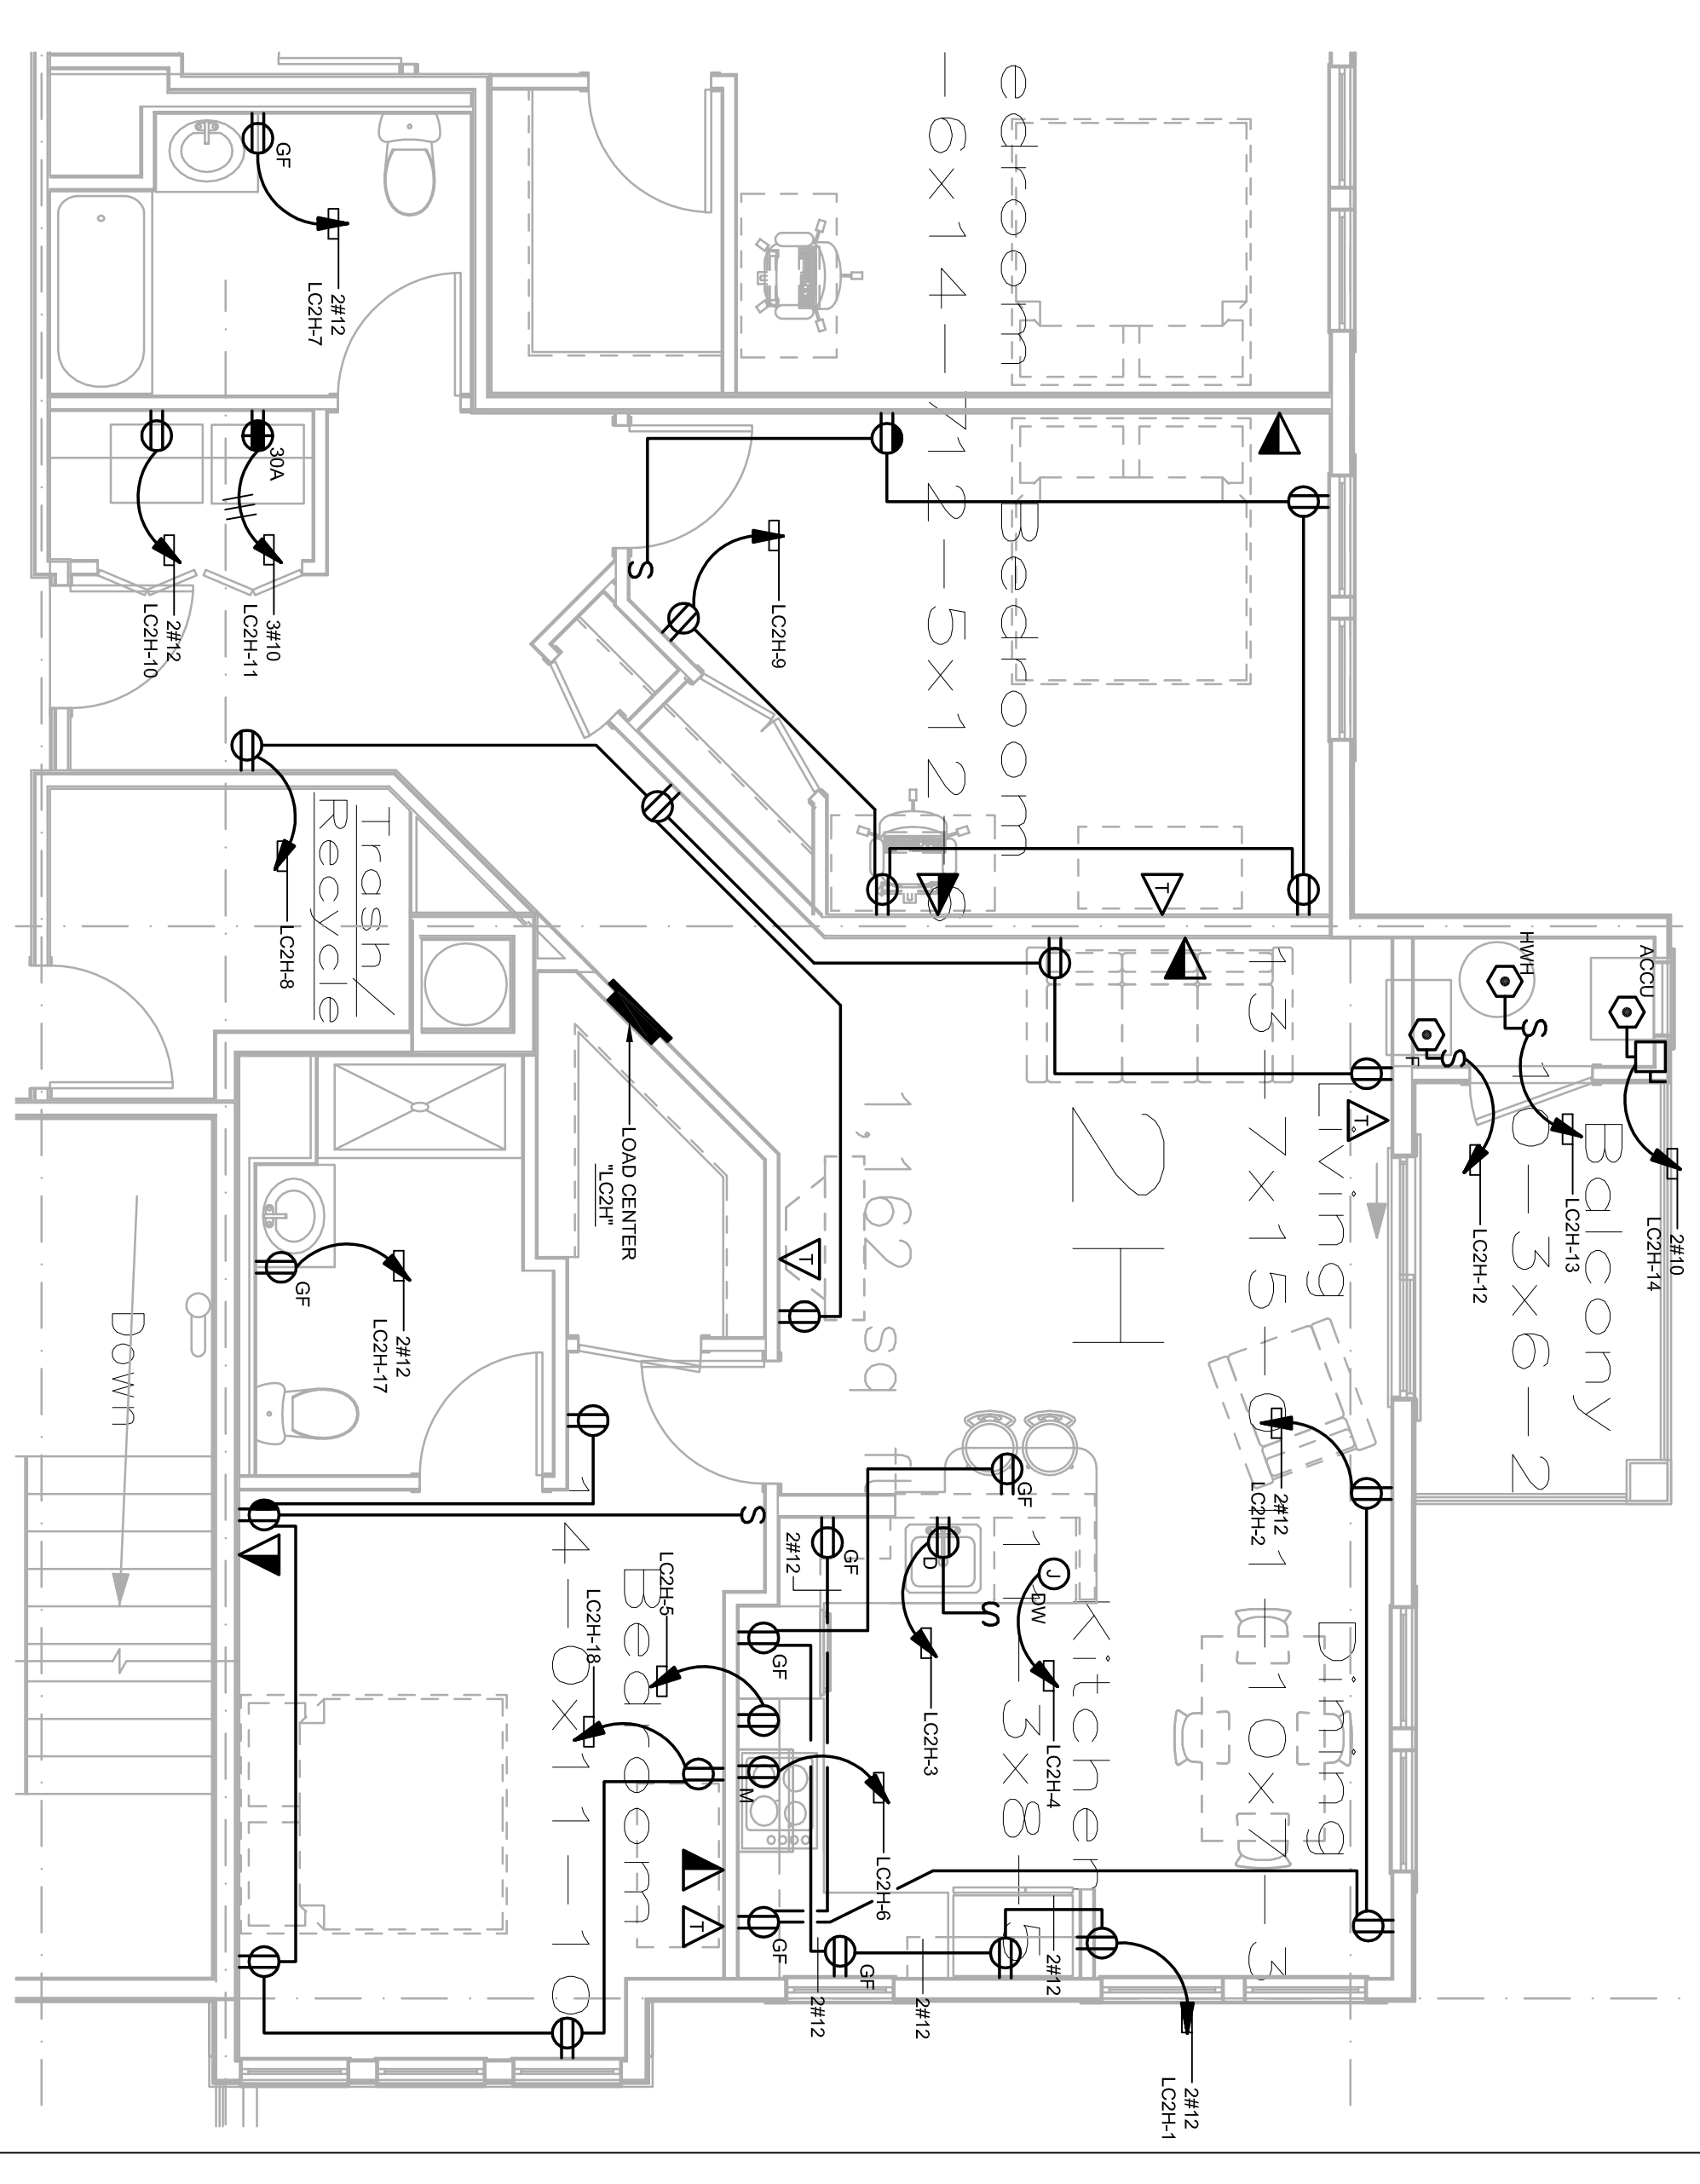


UNIT '2H' ELECTRICAL PLAN  
SCALE: 1/4" = 1'-0"

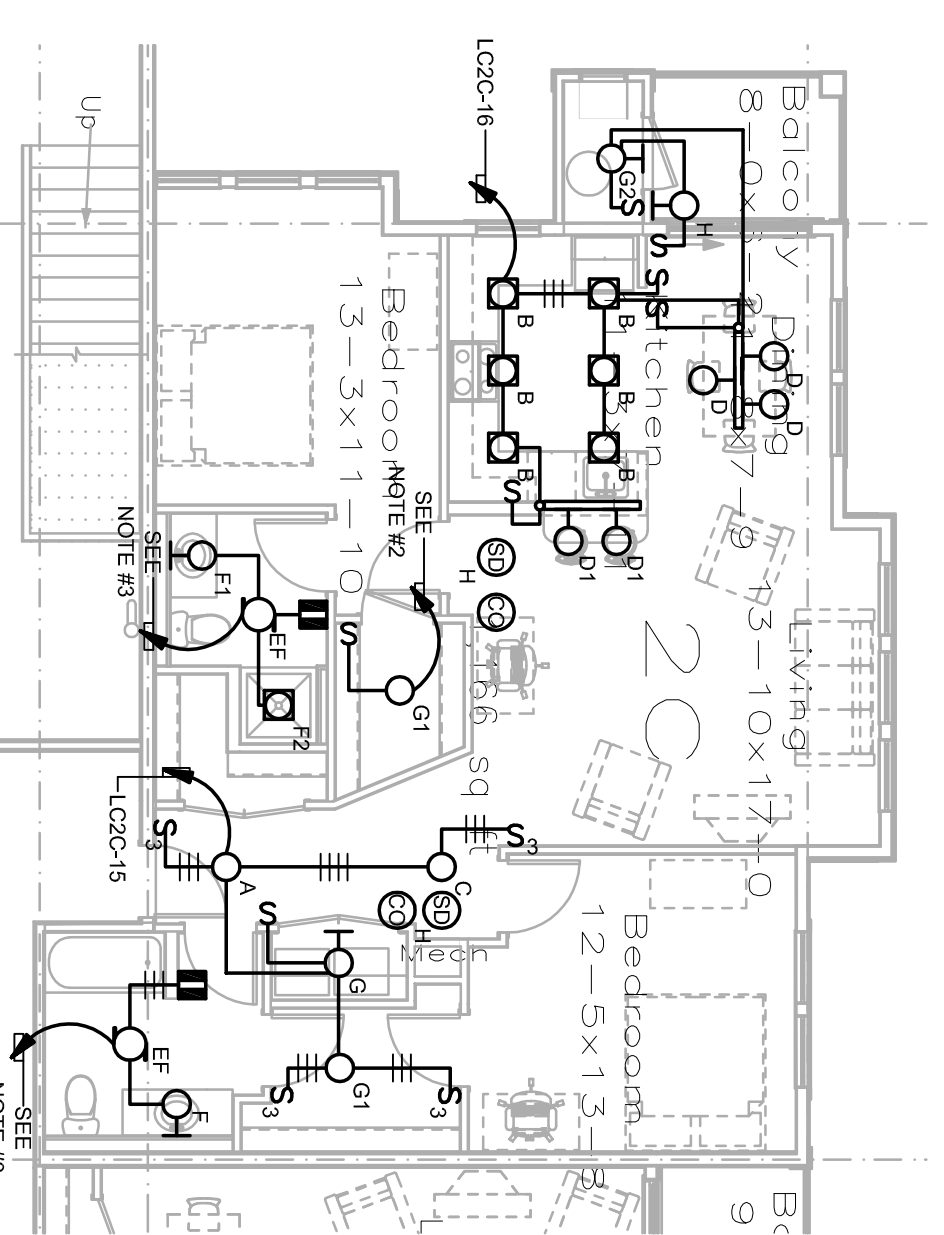

UNIT '2C' LIGHTING PLAN  
SCALE: 1/8" = 1'-0"

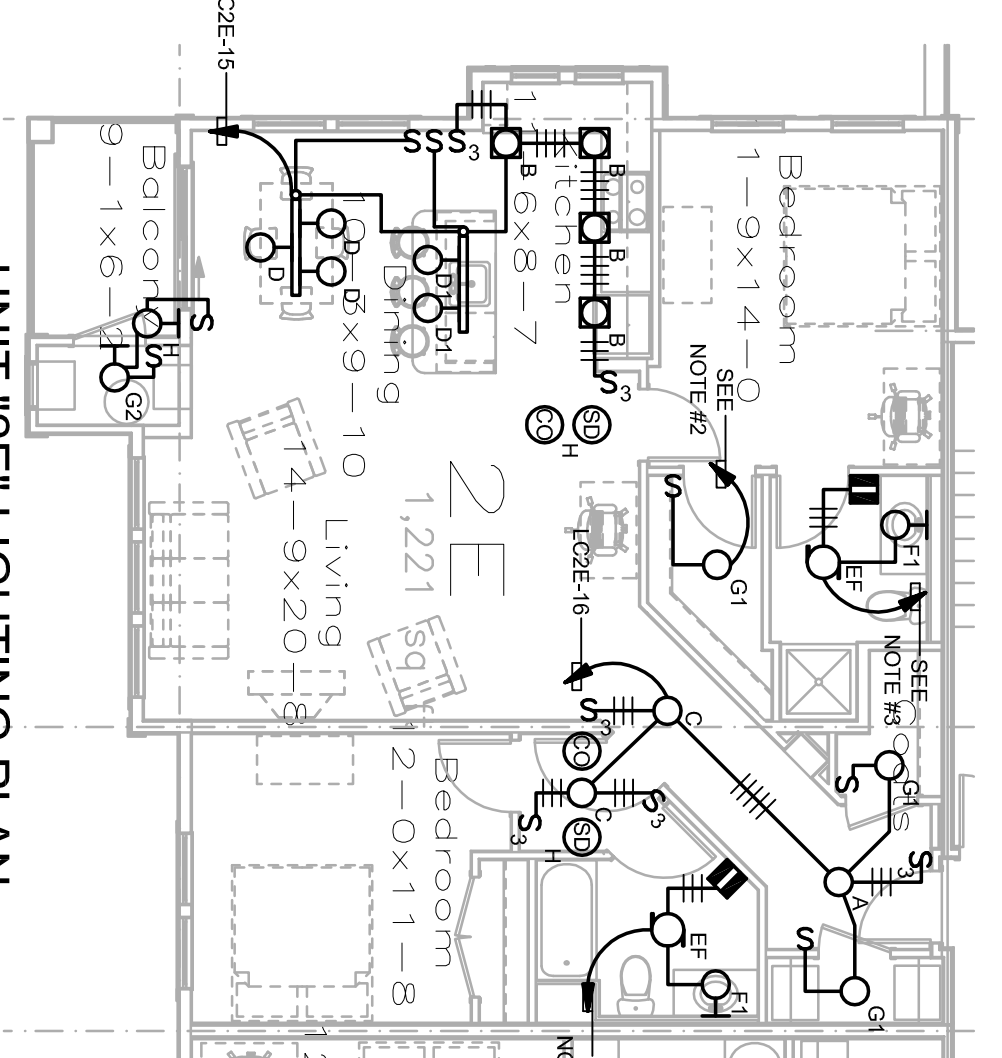

UNIT '2E' LIGHTING PLAN  
SCALE: 1/8" = 1'-0"

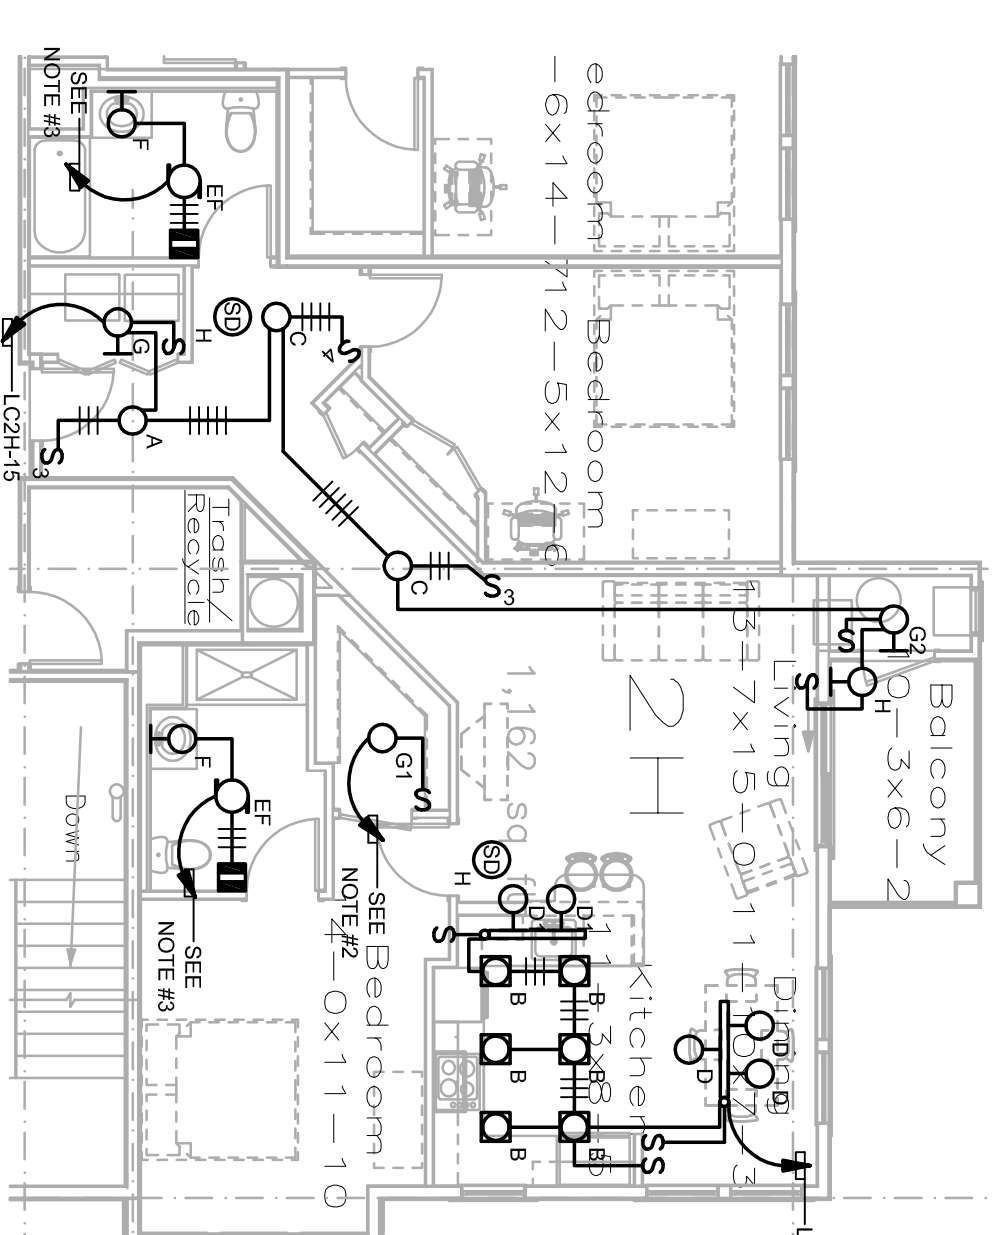

UNIT '2H' LIGHTING PLAN  
SCALE: 1/8" = 1'-0"

- NOTES:
1. THE ELECTRICAL CONTRACTOR SHALL REFER TO THE MECHANICAL, PLUMBING AND FIRE PROTECTION DRAWINGS FOR THE EXACT LOCATION OF ALL MECHANICAL, PLUMBING AND FIRE PROTECTION EQUIPMENT.
  2. THE ELECTRICAL CONTRACTOR SHALL WIRE TO NEAREST AVAILABLE SWITCH OR RECEPTACLE FOR ALL SWITCHES AND RECEPTACLES.
  3. THE ELECTRICAL CONTRACTOR SHALL WIRE TO THE ENTHROOM BRANCH CIRCUIT FEED OF THE BATHROOM GROUND FAULT RECEPTACLE.